


--- ADJ. PLOT 2828149 ---

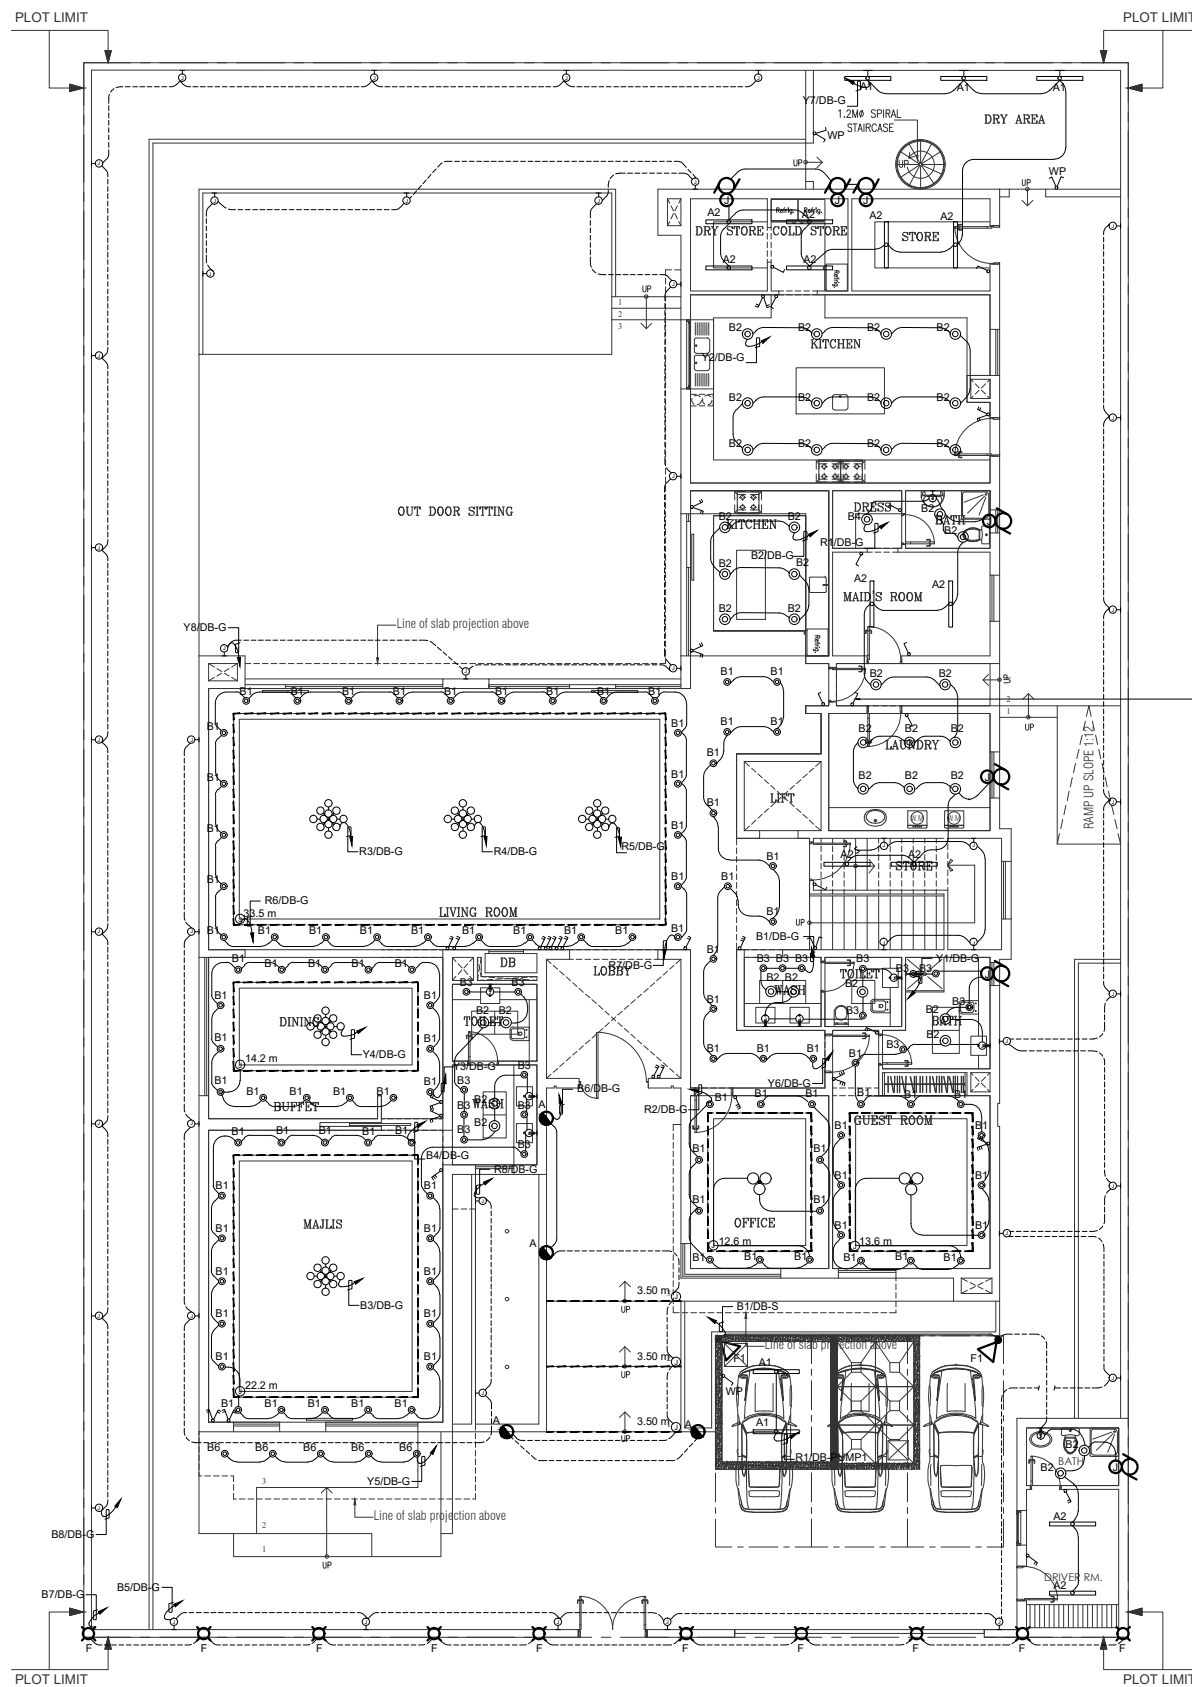

- FOR FENCE ,FACADE AND LANDSCAPE NO.(18)
- B2/DB-F. FACADE LIGHT@ FIRST
 - R2/DB-R. FACADE LIGHT@ ROOF
 - Y3/DB-R. FACADE LIGHT@ ROOF
 - R4/DB-R. FACADE LIGHT@ ROOF
 - B8/DB-R. FACADE LIGHT@ ROOF
 - R9/DB-R. FACADE LIGHT@ ROOF
 - Y9/DB-R. FACADE LIGHT@ ROOF
 - B3/DB-R. FLOOD LIGHT@ ROOF
 - Y5/DB-R. FLOOD LIGHT@ ROOF
 - R5/DB-F. DOWN LIGHT@ FIRST
 - R3/DB-R. DOWN LIGHT@ FIRST
 - Y5/DB-G. DOWN LIGHT@ GROUND
 - R8/DB-G. WALL WASHER @ OUTDOOR
 - Y8/DB-G. WALL WASHER @ OUTDOOR
 - B5/DB-G. FENCE @ OUTDOOR
 - B9/DB-G. FENCE @ OUTDOOR
 - B8/DB-G. FENCE @ OUTDOOR
 - B6/DB-G. STAIR @ OUTDOOR

--- ADJ. PLOT 2828118 ---

--- ADJ. PLOT 2828092 ---

--- ROAD 18.50 ---

GROUND FLOOR PLAN
SCALE 1:100

PLOT	2828116
ZONE	AL KHWANEJ SECOND
PHASE	
DESIGN HEIGHT: G+1 + Roof	CONSTRUCTION: G+1 + Roof

NOTE:
THESE DRAWINGS ARE FOR INFORMATION & USE FOR COST ESTIMATE ONLY.
THIS DRAWINGS WILL NOT BE USE FOR ANY CONSTRUCTION PROGRESSES.
AUTHORITY REVIEW AND APPROVAL IS IN PROCESS AND ANY COMMENTS OR FURTHER REQUIREMENTS ON THE DESIGN WILL BE MODIFIED IF NECESSARY.

REV.	DATE	DESCRIPTIONS	BY ENG.	CHECK

CLIENT:
SAEED YOUSUF ABDULLA MOHAMMAD SHAKARI



PROJECT:
**PROPOSED PRIVATE VILLA
(G+1 +Roof)**

PROJECT NO.:	ADC- 000
DESIGNED BY:	STRUC. ENG. :
ARCH. ENG. :	M.E.P. ENG. :

DRAWING TITLE:
**LIGHTING SYSTEM
GROUND FLOOR PLAN**

DRAWING NO.:	E201	DATE:	JULY 2021
DRAWN BY:	CHECKED BY:	SCALE:	1:100
SERIAL NO.		REV.NO :	